


SECTION J 401 BACKDRAFT DAMPER DETAIL
SCALE = 1:10

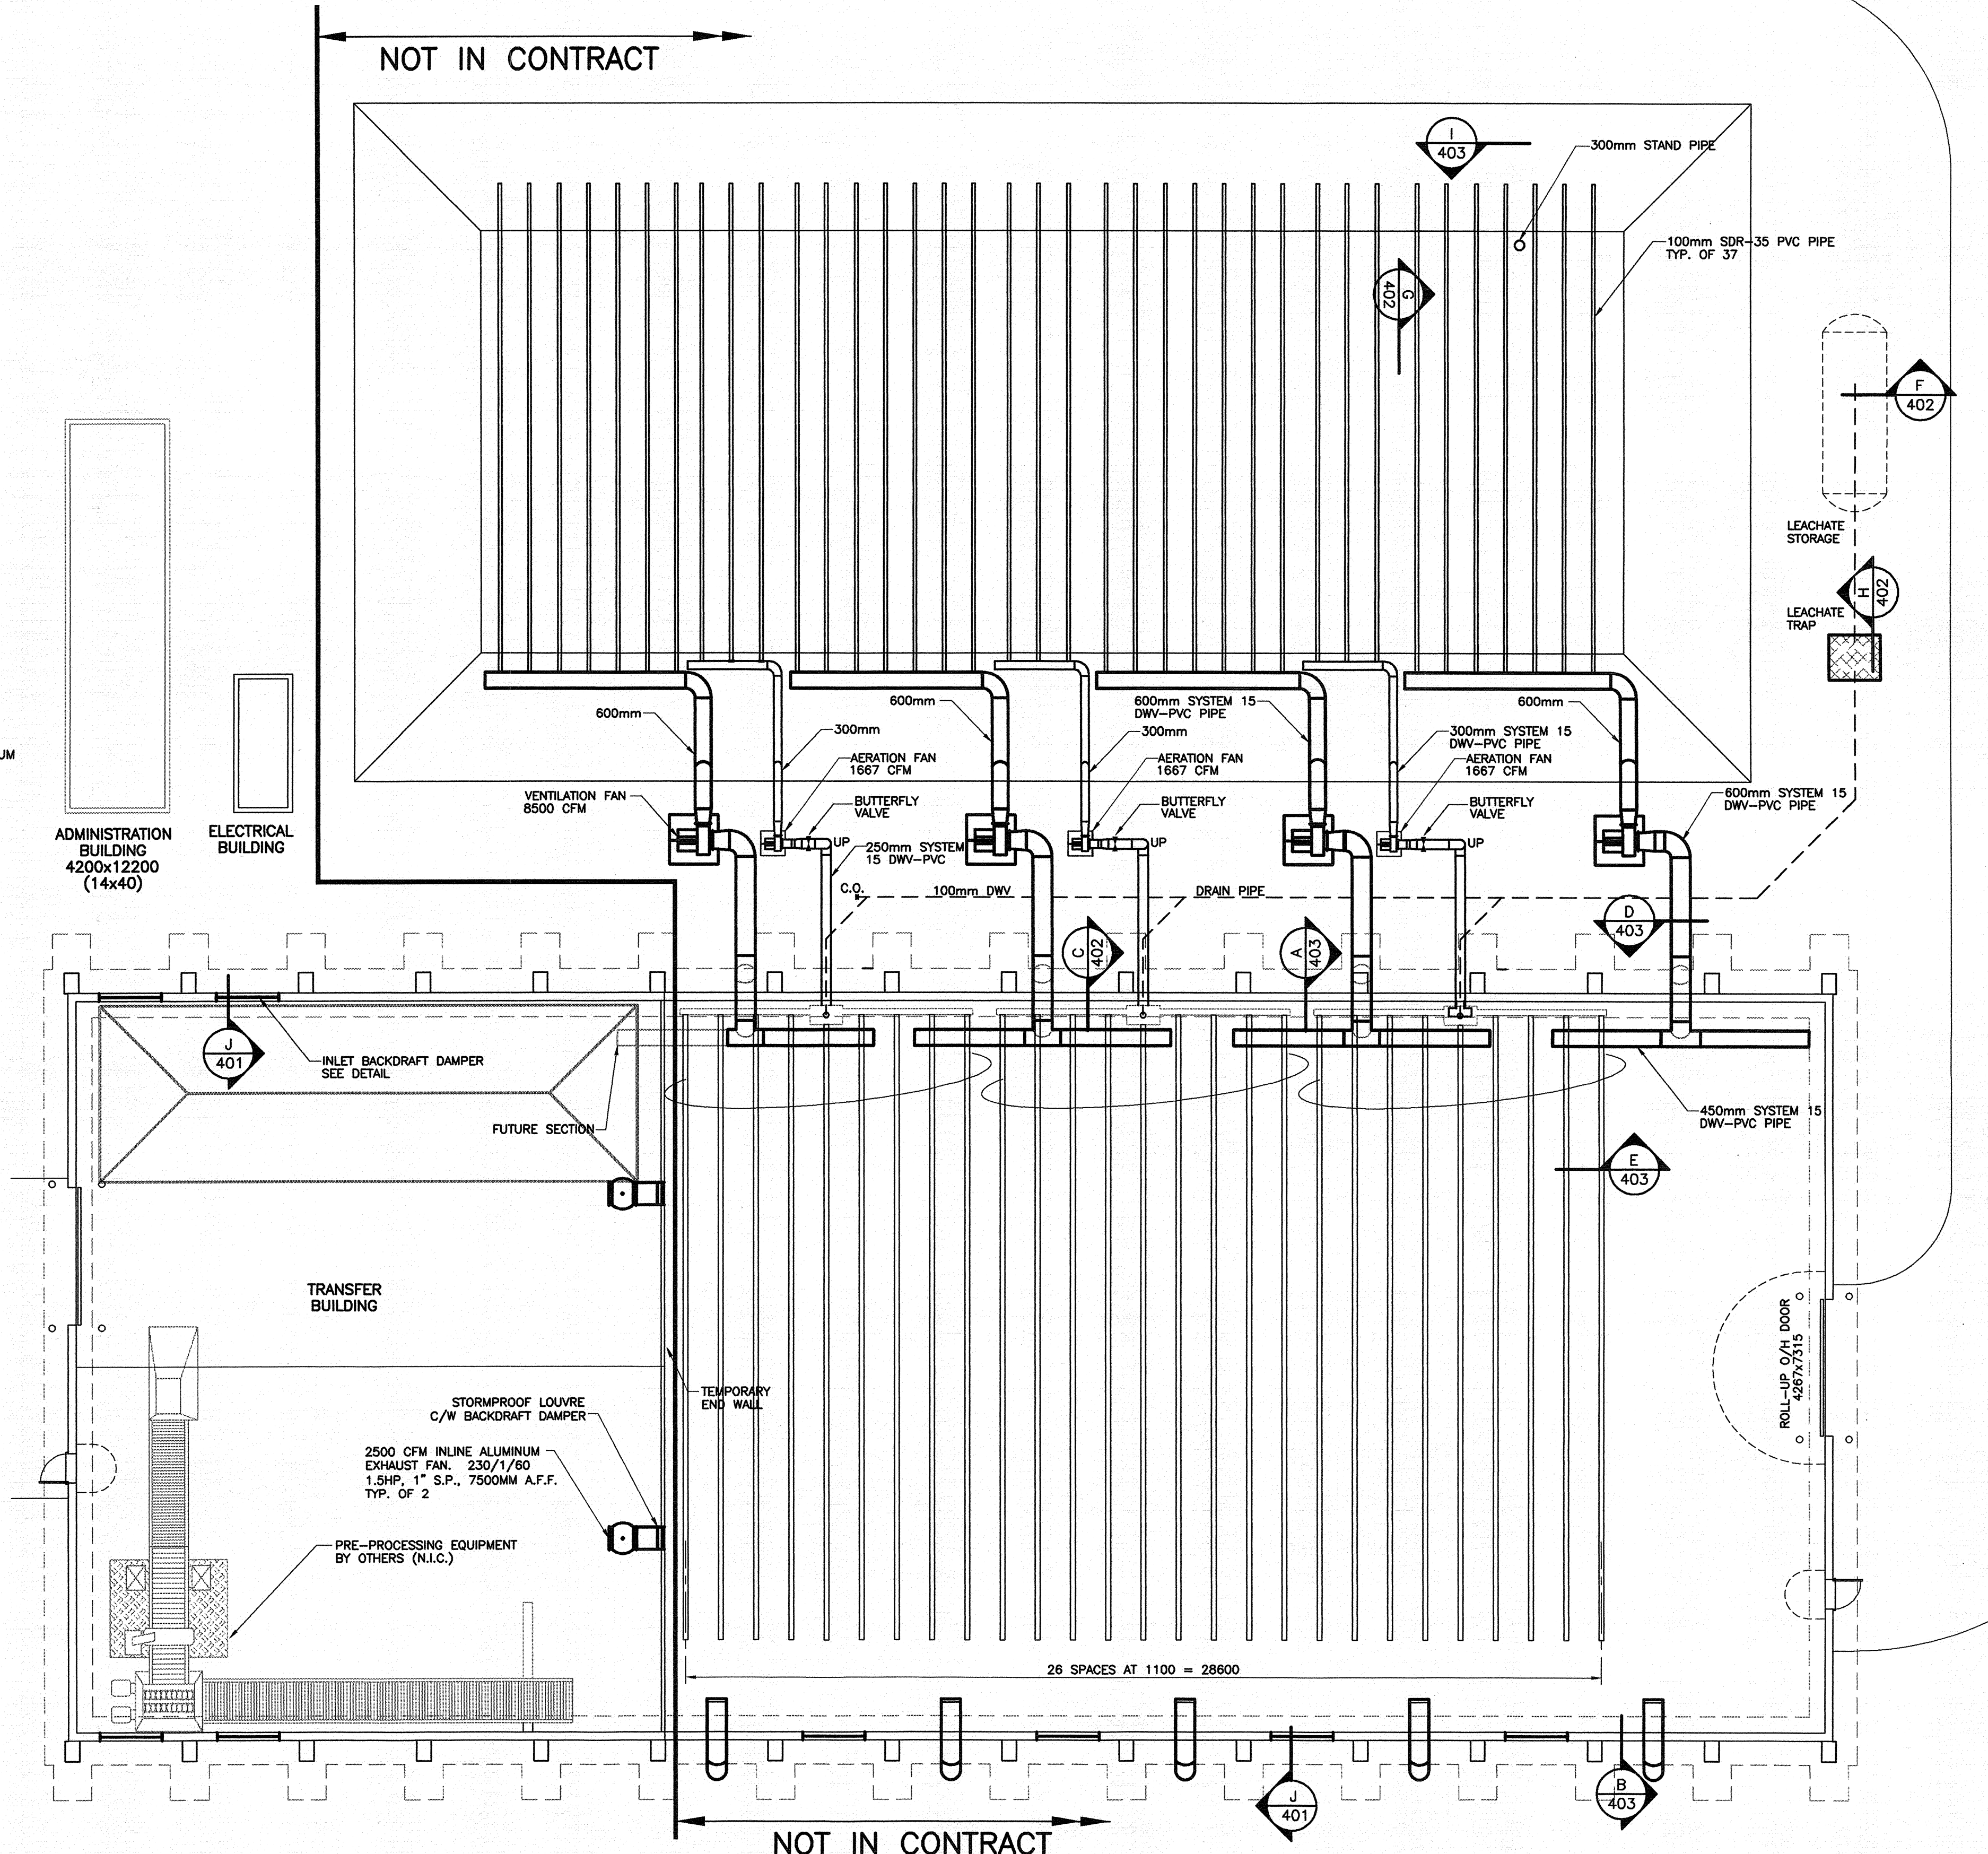

BUILDING PLAN
Scale = 1:125

NOTE:

1. TOP OF CLEAN OUT TO EXTEND 300 ABOVE FINISH GRADE. (LEACHATE DRAIN ONLY)(NIC)

ISSUED FOR CONSTRUCTION

REV	DATE	BY	DESCRIPTION
2			
1	01/11/13	MDT	ISSUED FOR CONSTRUCTION
0	01/08/22	Y.K.	ISSUED FOR TENDER

REVISIONS



Vaughan Engineering
A member of the MacDonnell Group • Technology and Consulting Solutions

CLIENT			Municipality of East Hants		
PROJECT TITLE					
East Hants Composting Facility					
DRAWING TITLE					
MECHANICAL LAYOUT					
DATE		01-08-21		STAMP	
CHECKED		R.H.			
DRAWN		Y.K.			
DESIGNED		Y.K.			
SURVEYED		N/A			
SCALE		1 : 125			
APPROVED				20	JOB NO.
-----					3257
APPROVED				20	SHEET
-----					401
VAUGHAN COMPUTER FILE 3257-401-A-1 REV. 1					