

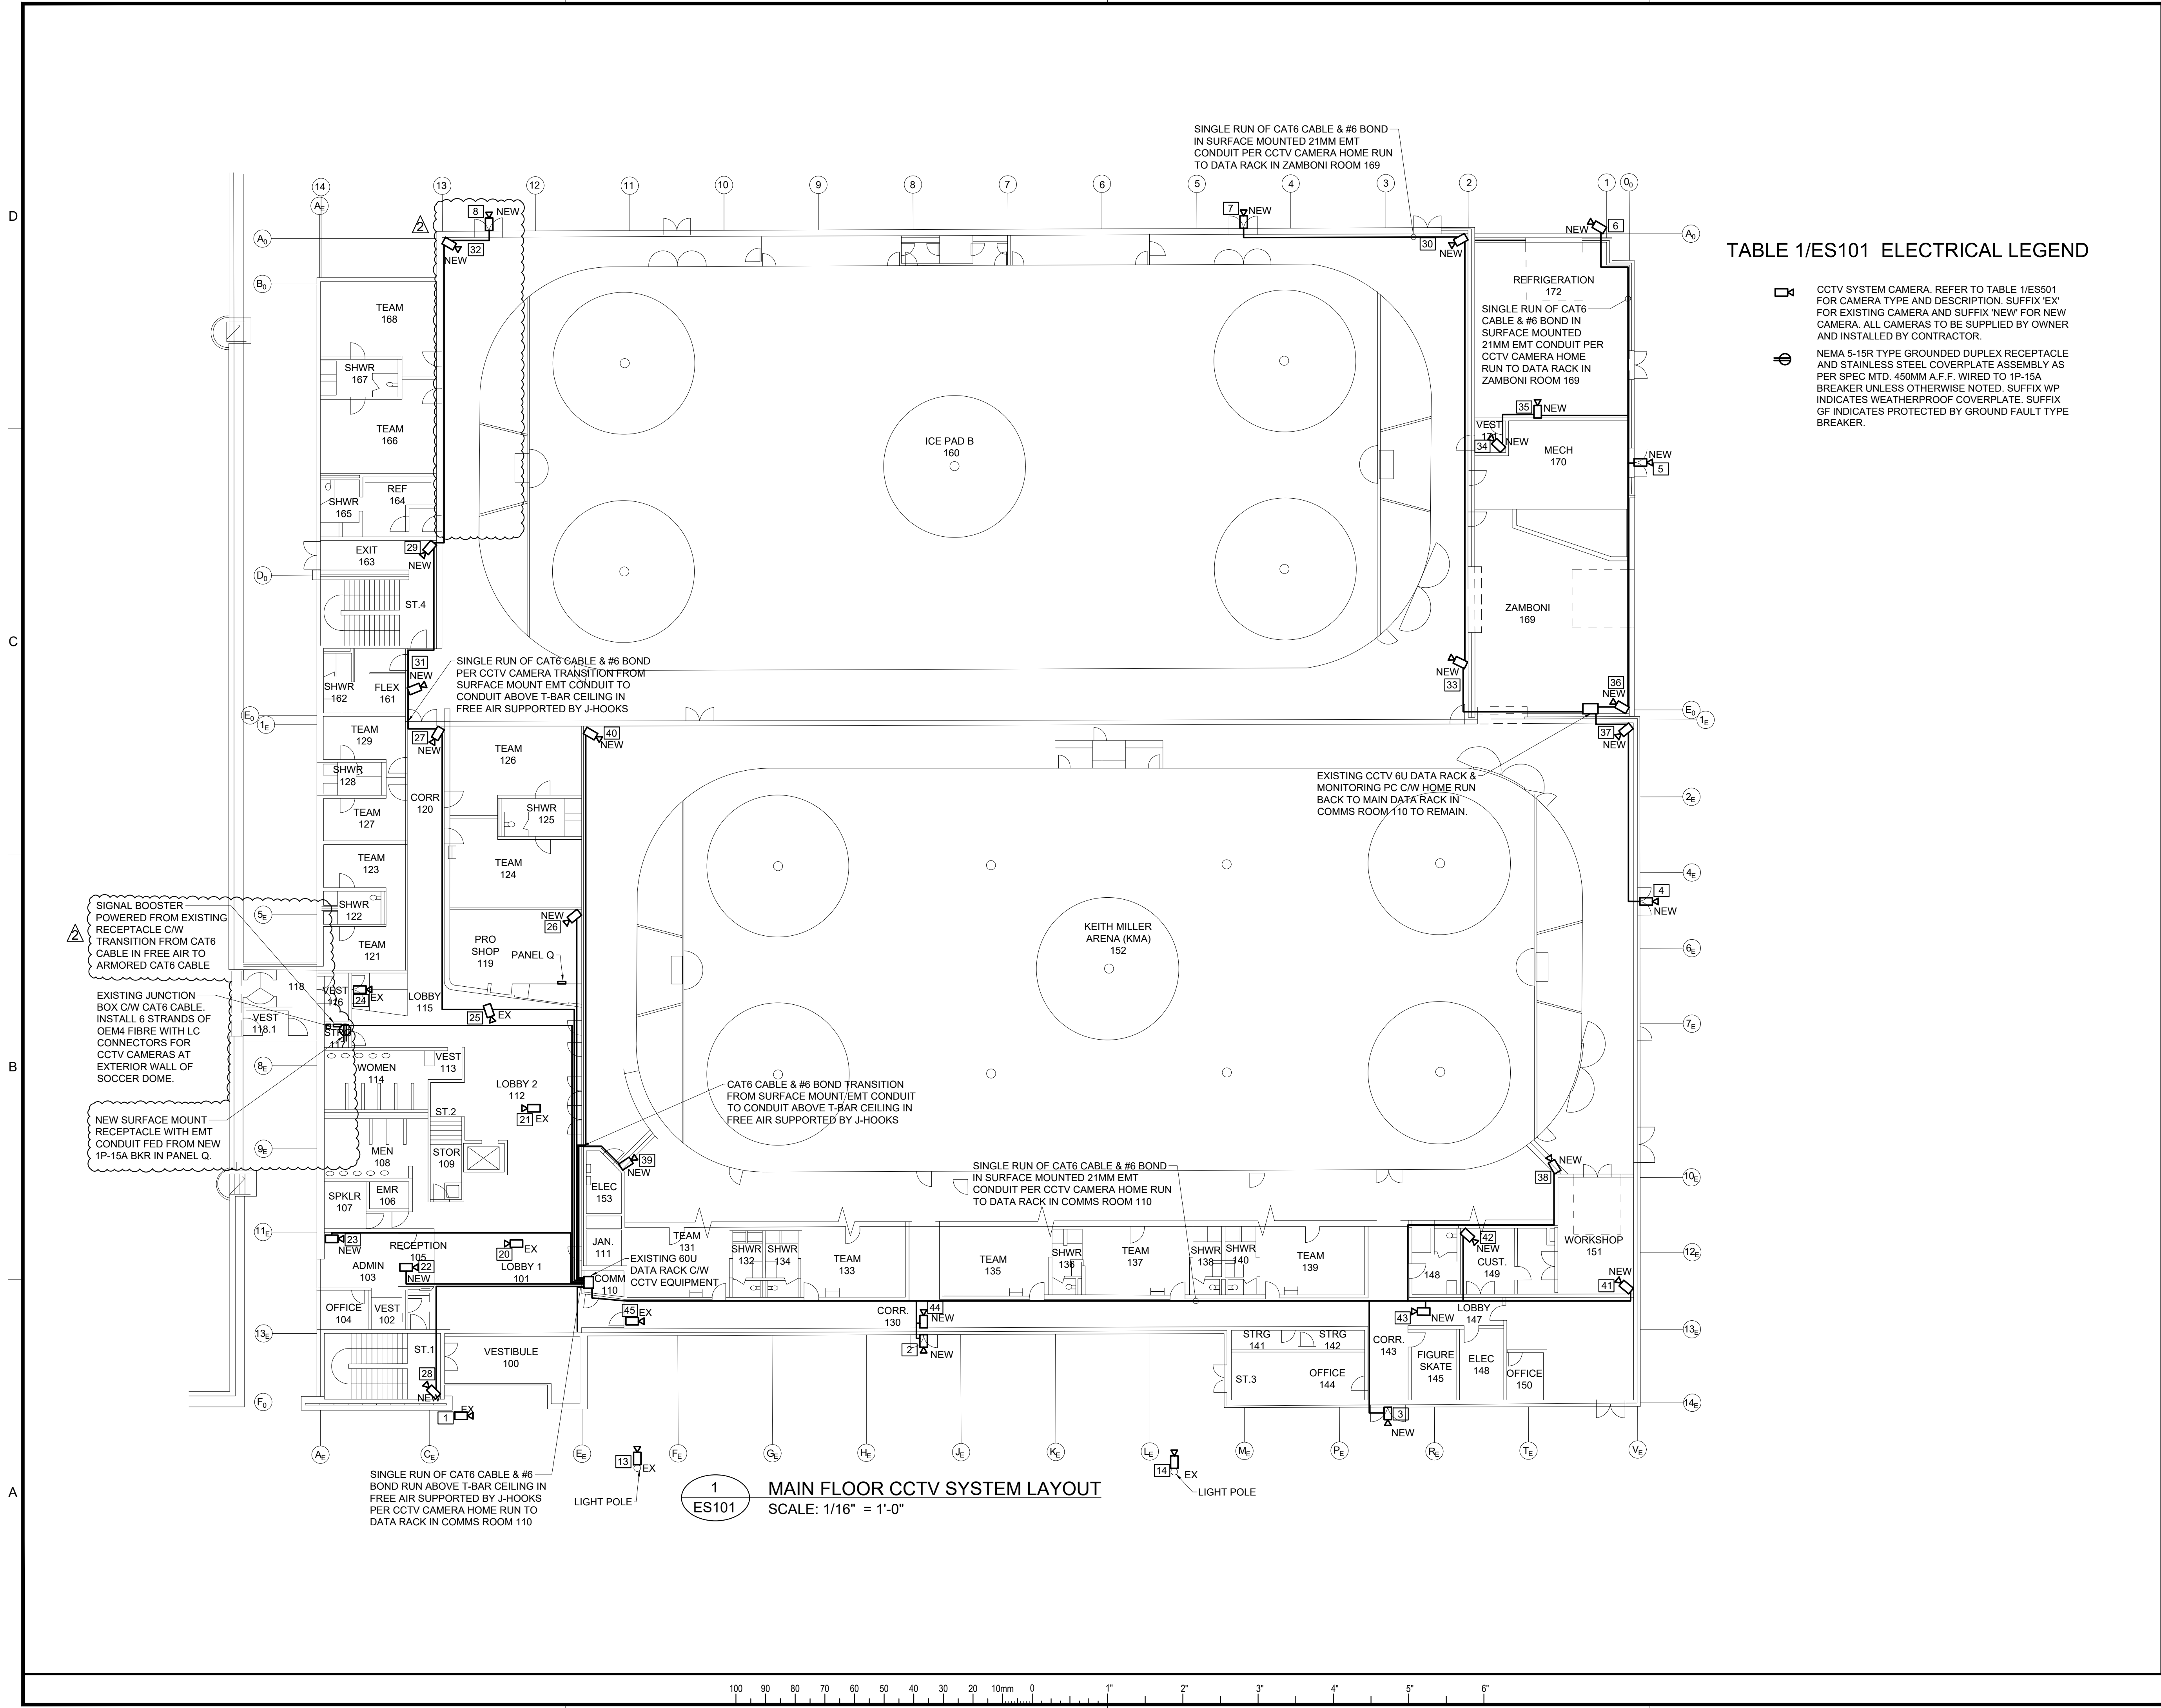


TABLE 1/ES101 ELECTRICAL LEGEND

- CCTV SYSTEM CAMERA. REFER TO TABLE 1/ES501 FOR CAMERA TYPE AND DESCRIPTION. SUFFIX 'EX' FOR EXISTING CAMERA AND SUFFIX 'NEW' FOR NEW CAMERA. ALL CAMERAS TO BE SUPPLIED BY OWNER AND INSTALLED BY CONTRACTOR.
- NEMA 5-15R TYPE GROUNDED DUPLEX RECEPTACLE AND STAINLESS STEEL COVERPLATE ASSEMBLY AS PER SPEC MTD. 450MM A.F.F. WIRED TO 1P-15A BREAKER UNLESS OTHERWISE NOTED. SUFFIX WP INDICATES WEATHERPROOF COVERPLATE. SUFFIX GF INDICATES PROTECTED BY GROUND FAULT TYPE BREAKER.

KEY PLAN

Architectural Consultants

Mechanical and Electrical Consultants

A.H. Roy
& Associates Ltd.
275 Main Street - Suite 100
Antigonish, N.S. B2G 2C3
Tel: (902) 863-2955 E-mail: aroyoffice@ahroy.ca

A.H.ROY FILE #: 2025-4021

GRAPHIC SCALE

2026/06/19	2	ELEC ADDENDUM 1
2026/06/05	1	ISSUED FOR TENDER
DATE	MARK	ISSUE

STAMP



SCALE 1/16" = 1'-0"
DRAWN BY: TM
CHECKED BY: EL
REVIEWED BY: DD
APPROVED BY: -
AS-BUILT CHECK -
DATE: JUNE 2026

PROJECT
EAST HANTS SPORTSPLEX -
DOOR ACCESS CONTROL AND
CCTV STRUCTURED CABLING

1076 HIGHWAY 2, LANTZ, NS


PROJECT NO.:

SHEET TITLE
MAIN FLOOR CCTV SECURITY
SYSTEM LAYOUT

INTERNAL NO.:

ES101

SHEET - OF -

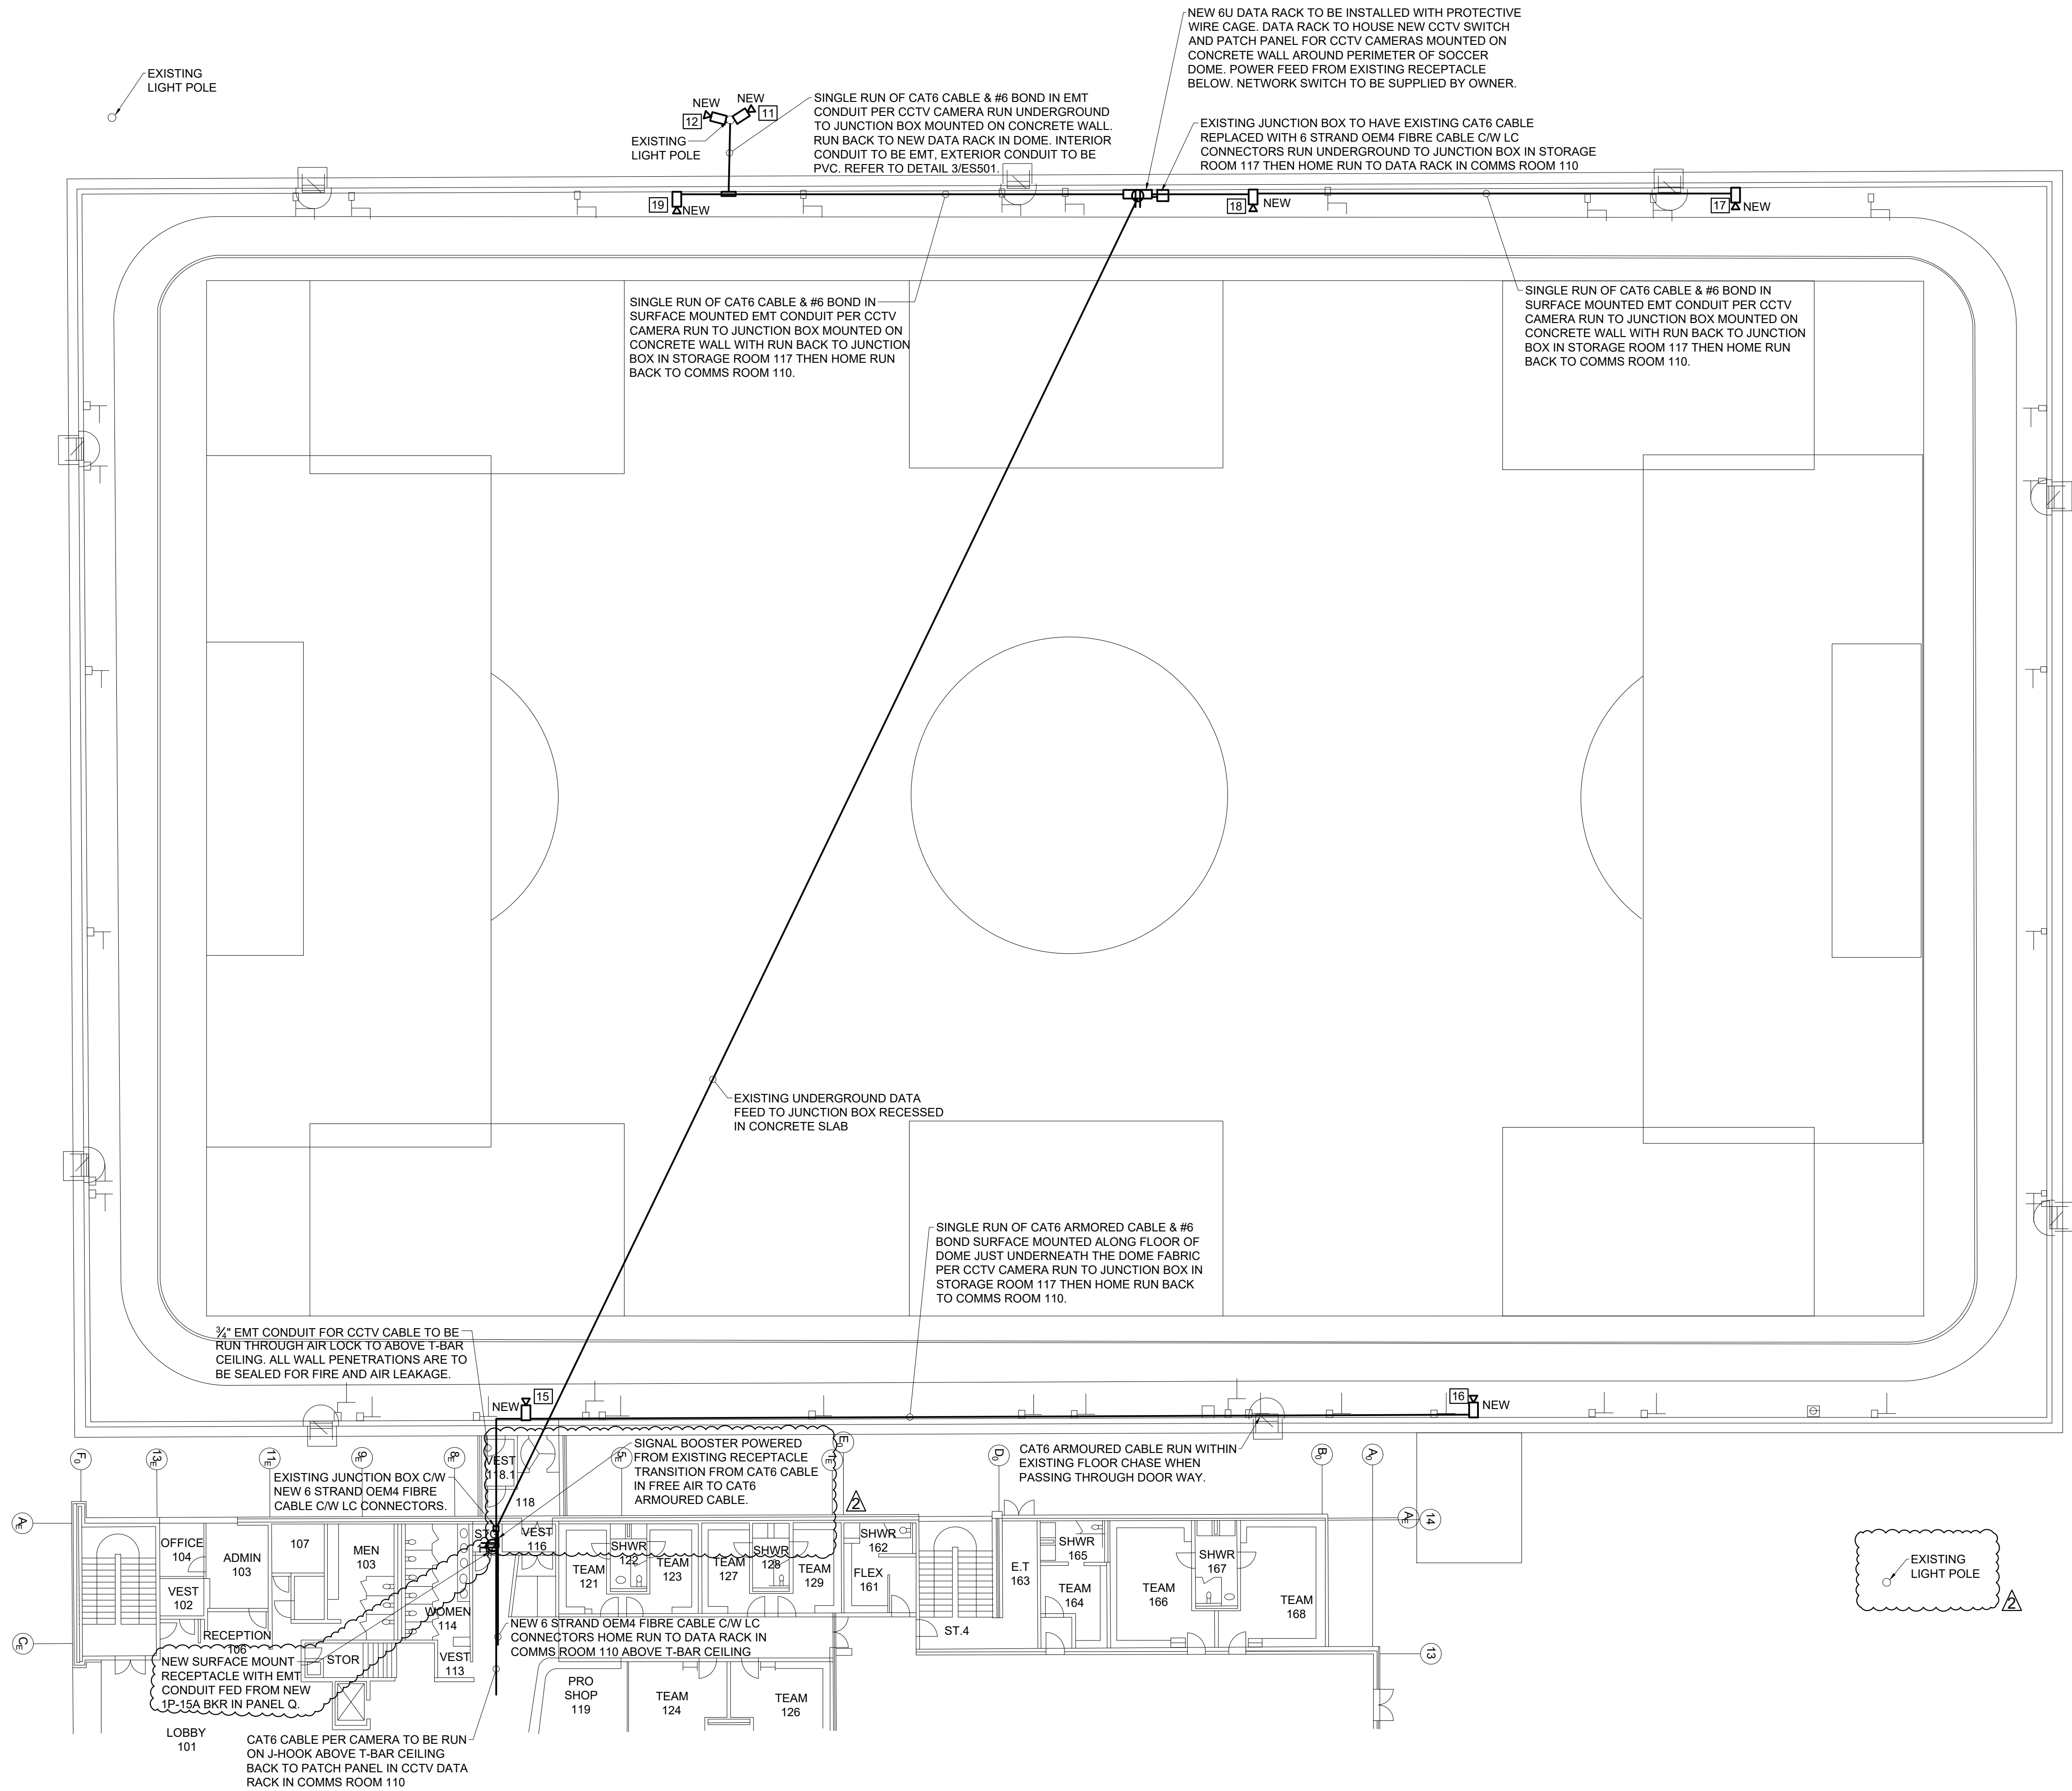


1
ES103

1 DOME CCTV SYSTEM LAYOUT
SCALE: 1/16" = 1'-0"

KEY PLAN

Architectural Consultants

Mechanical and Electrical Consultants

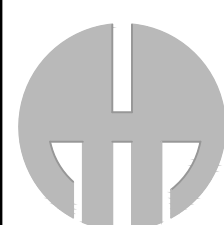 **A.H. Roy**
& Associates Ltd.
275 Main Street - Suite 100
Antigonish, N.S., B2G 2C3
Tel: (902) 863-2955 E-mail: ahroyoffice@ahroy.ca

A.H.ROY FILE #: 2025-4021

GRAPHIC SCALE

0	10mm	20	30	40	50	60	70	80	90	100
2026/06/19	2	ELEC ADDENDUM 1								
2026/06/05	1	ISSUED FOR TENDER								
DATE	MARK	ISSUE								

STAMP



SCALE 1/16" = 1'-0"

DRAWN BY: TM
CHECKED BY: EL
REVIEWED BY: DD
APPROVED BY: -
AS-BUILT CHECK -
DATE: JUNE 2026

PROJECT
EAST HANTS SPORTSPLEX -
DOOR ACCESS CONTROL AND
CCTV STRUCTURED CABLING

1076 HIGHWAY 2, LANTZ, NS

PROJECT NO.:

SHEET TITLE
DOME CCTV SECURITY SYSTEM
LAYOUT

INTERNAL NO.:

ES103

SHEET - OF -